

15 PEABODY STREET PARK
Salem, MA
City of Salem

Salem City Hall
93 Washington Street
Salem, MA 01970
P: 978/4535959

TEAM

landworks>studio inc.

112 Shawmut Avenue - Suite 68
Boston, MA 02110
P: 617.423.7200
F: 617.423.1414
www.landworks-studio.com

10 Derby Square, 4th Floor
Salem, MA 01970
P: 617.426.3030
F: 617.426.3033
www.landworks-studio.com

LANDSCAPE ARCHITECT

utile

30 Summer Street
Boston, MA 02110
P: 617.423.1200
F: 617.423.1414
www.ultidesign.com

URBAN DESIGN

Vine

ASSOCIATES, INC.
372 Merrimac Street
Newburyport, MA 01950
P: 978.465.1428
F: 978.465.2540
www.vineassociates.net


CIVIL ENGINEER

Engineered Building Systems

22 Manchester Road, Suite 6A
Derry, NH 03038
603.870.9009 Main
603.432.4255 Fax


ELECTRICAL ENGINEER

STAMP

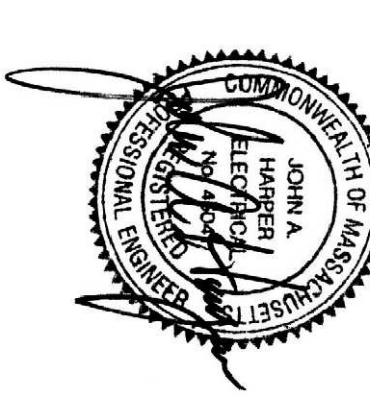

September 2, 2008
Bid Documents

 PROJECT NUMBER
0803




SCALE: N.T.S.

Park Electrical Plan


SE-4

MAIN SERVICE GROUNDING ELECTRODE SYSTEM DIAGRAM

N12.6

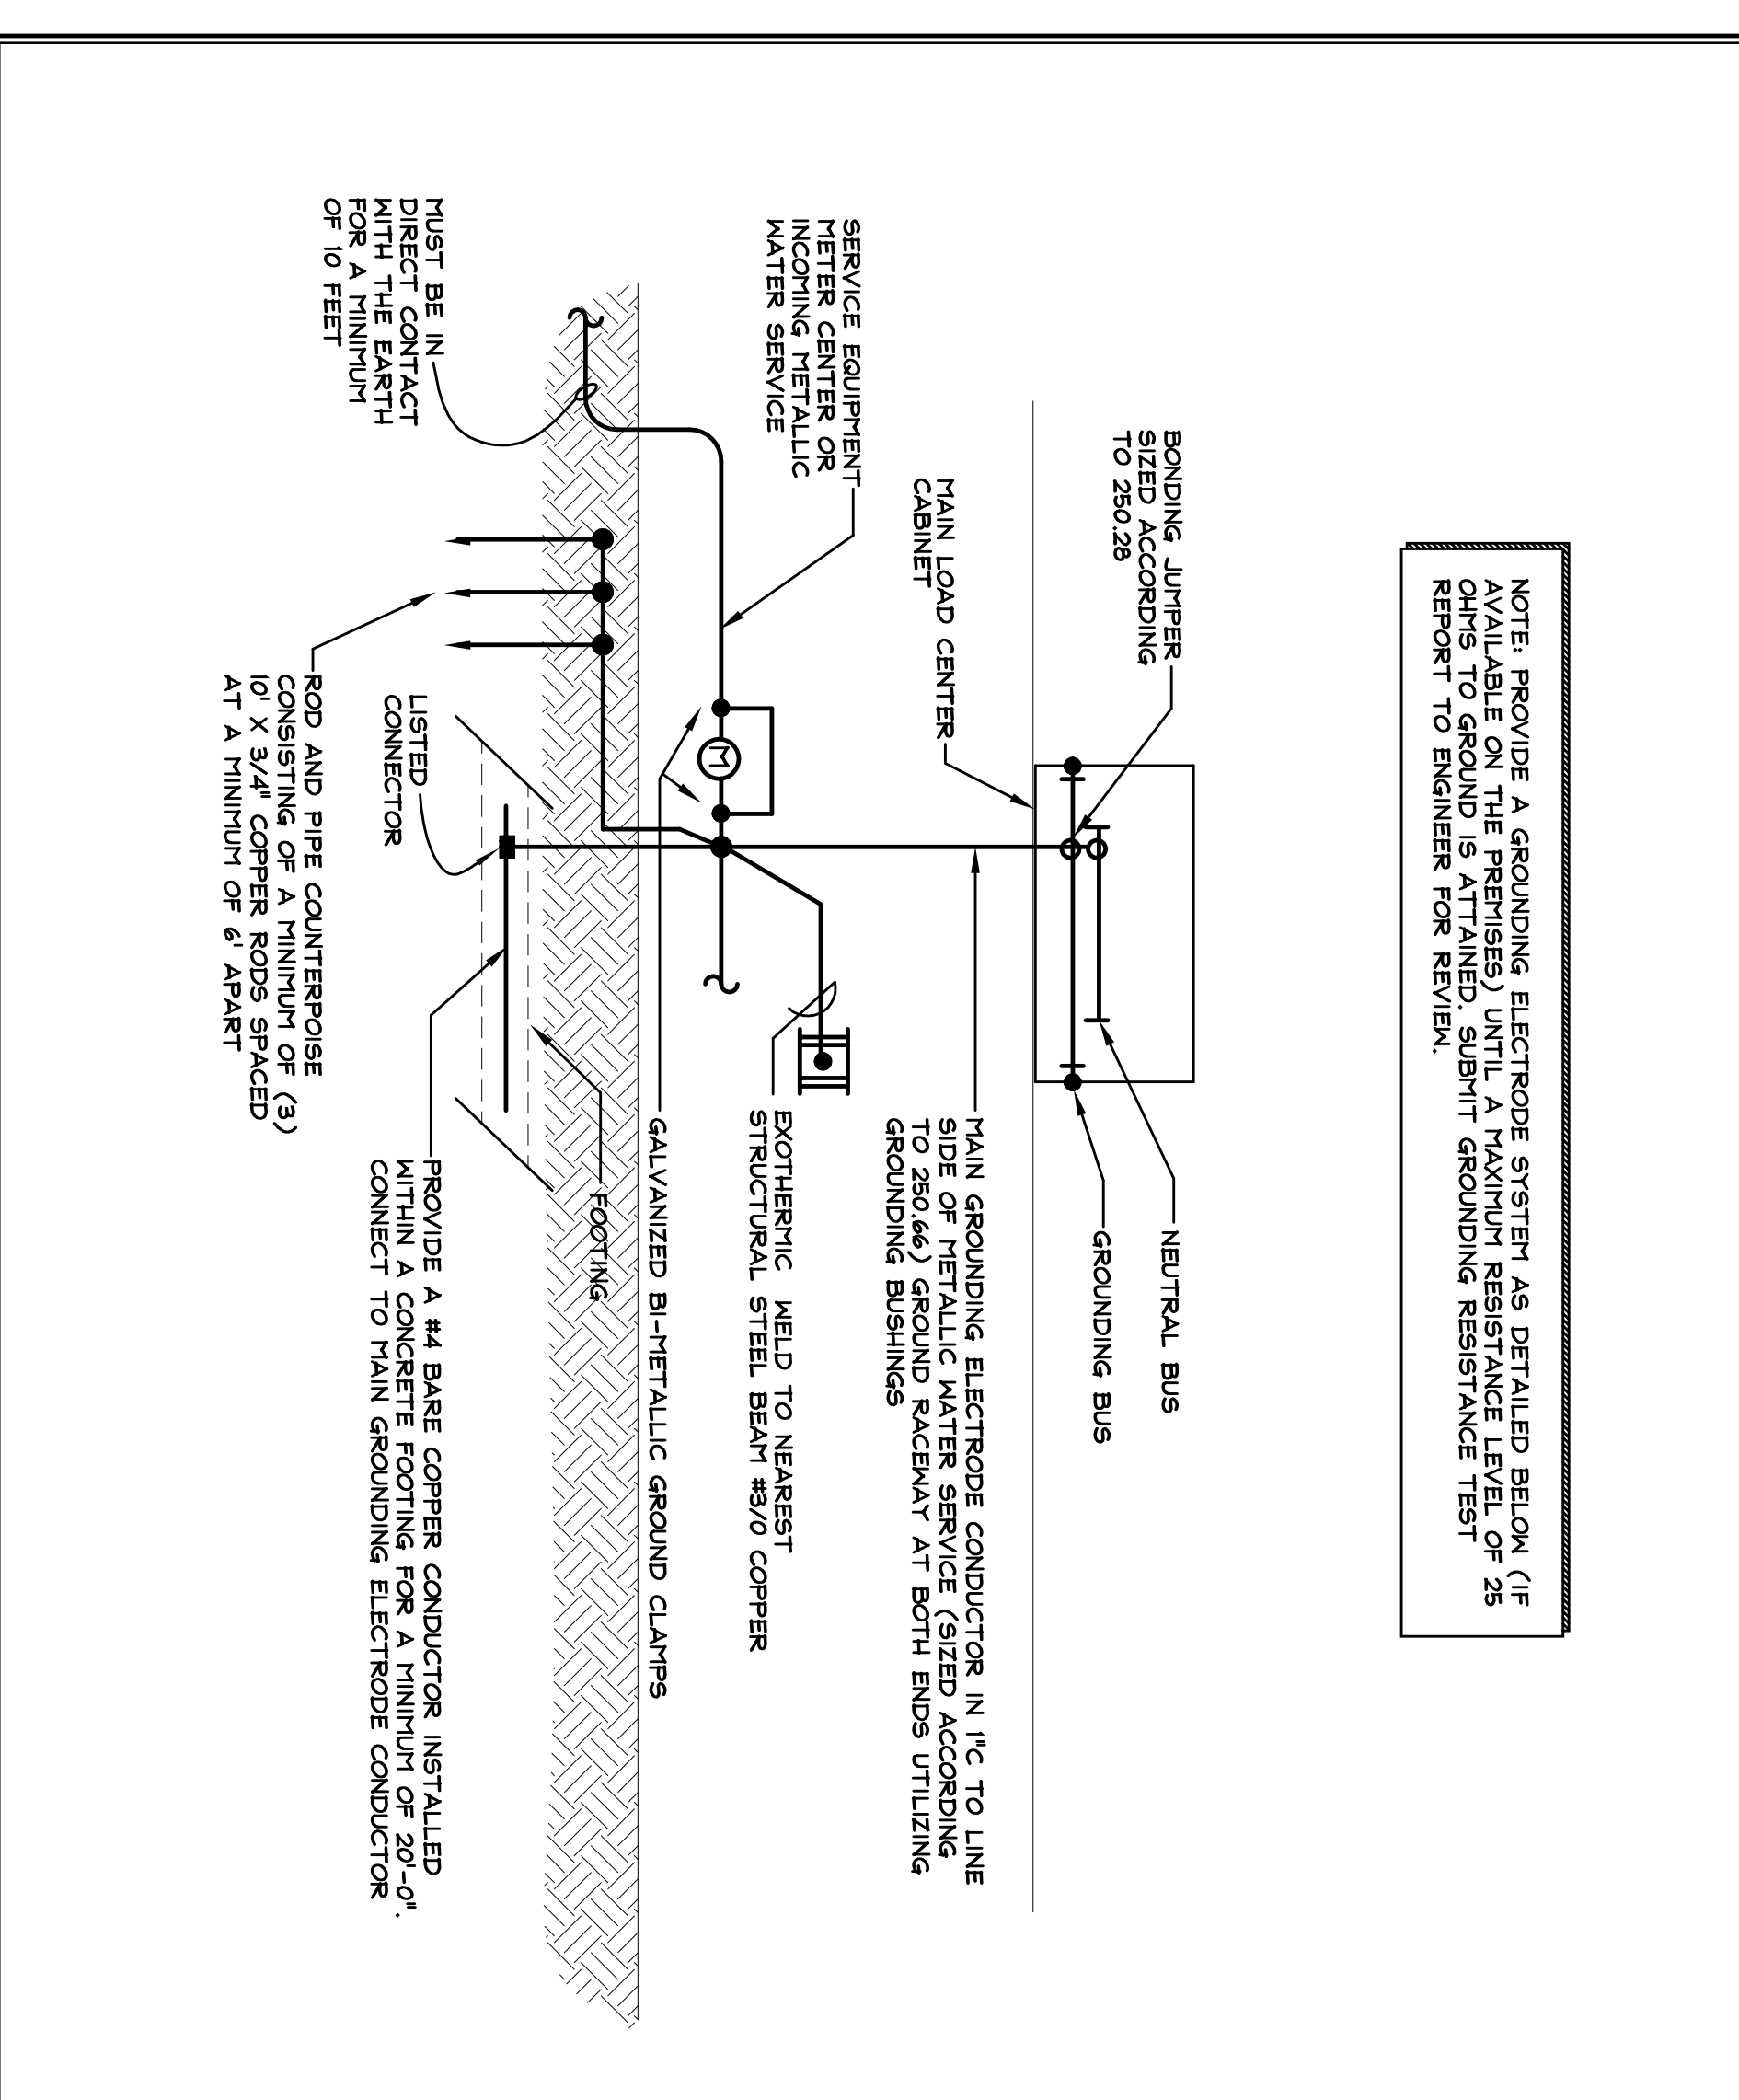

LOAD CENTER CABINET PAD DETAIL

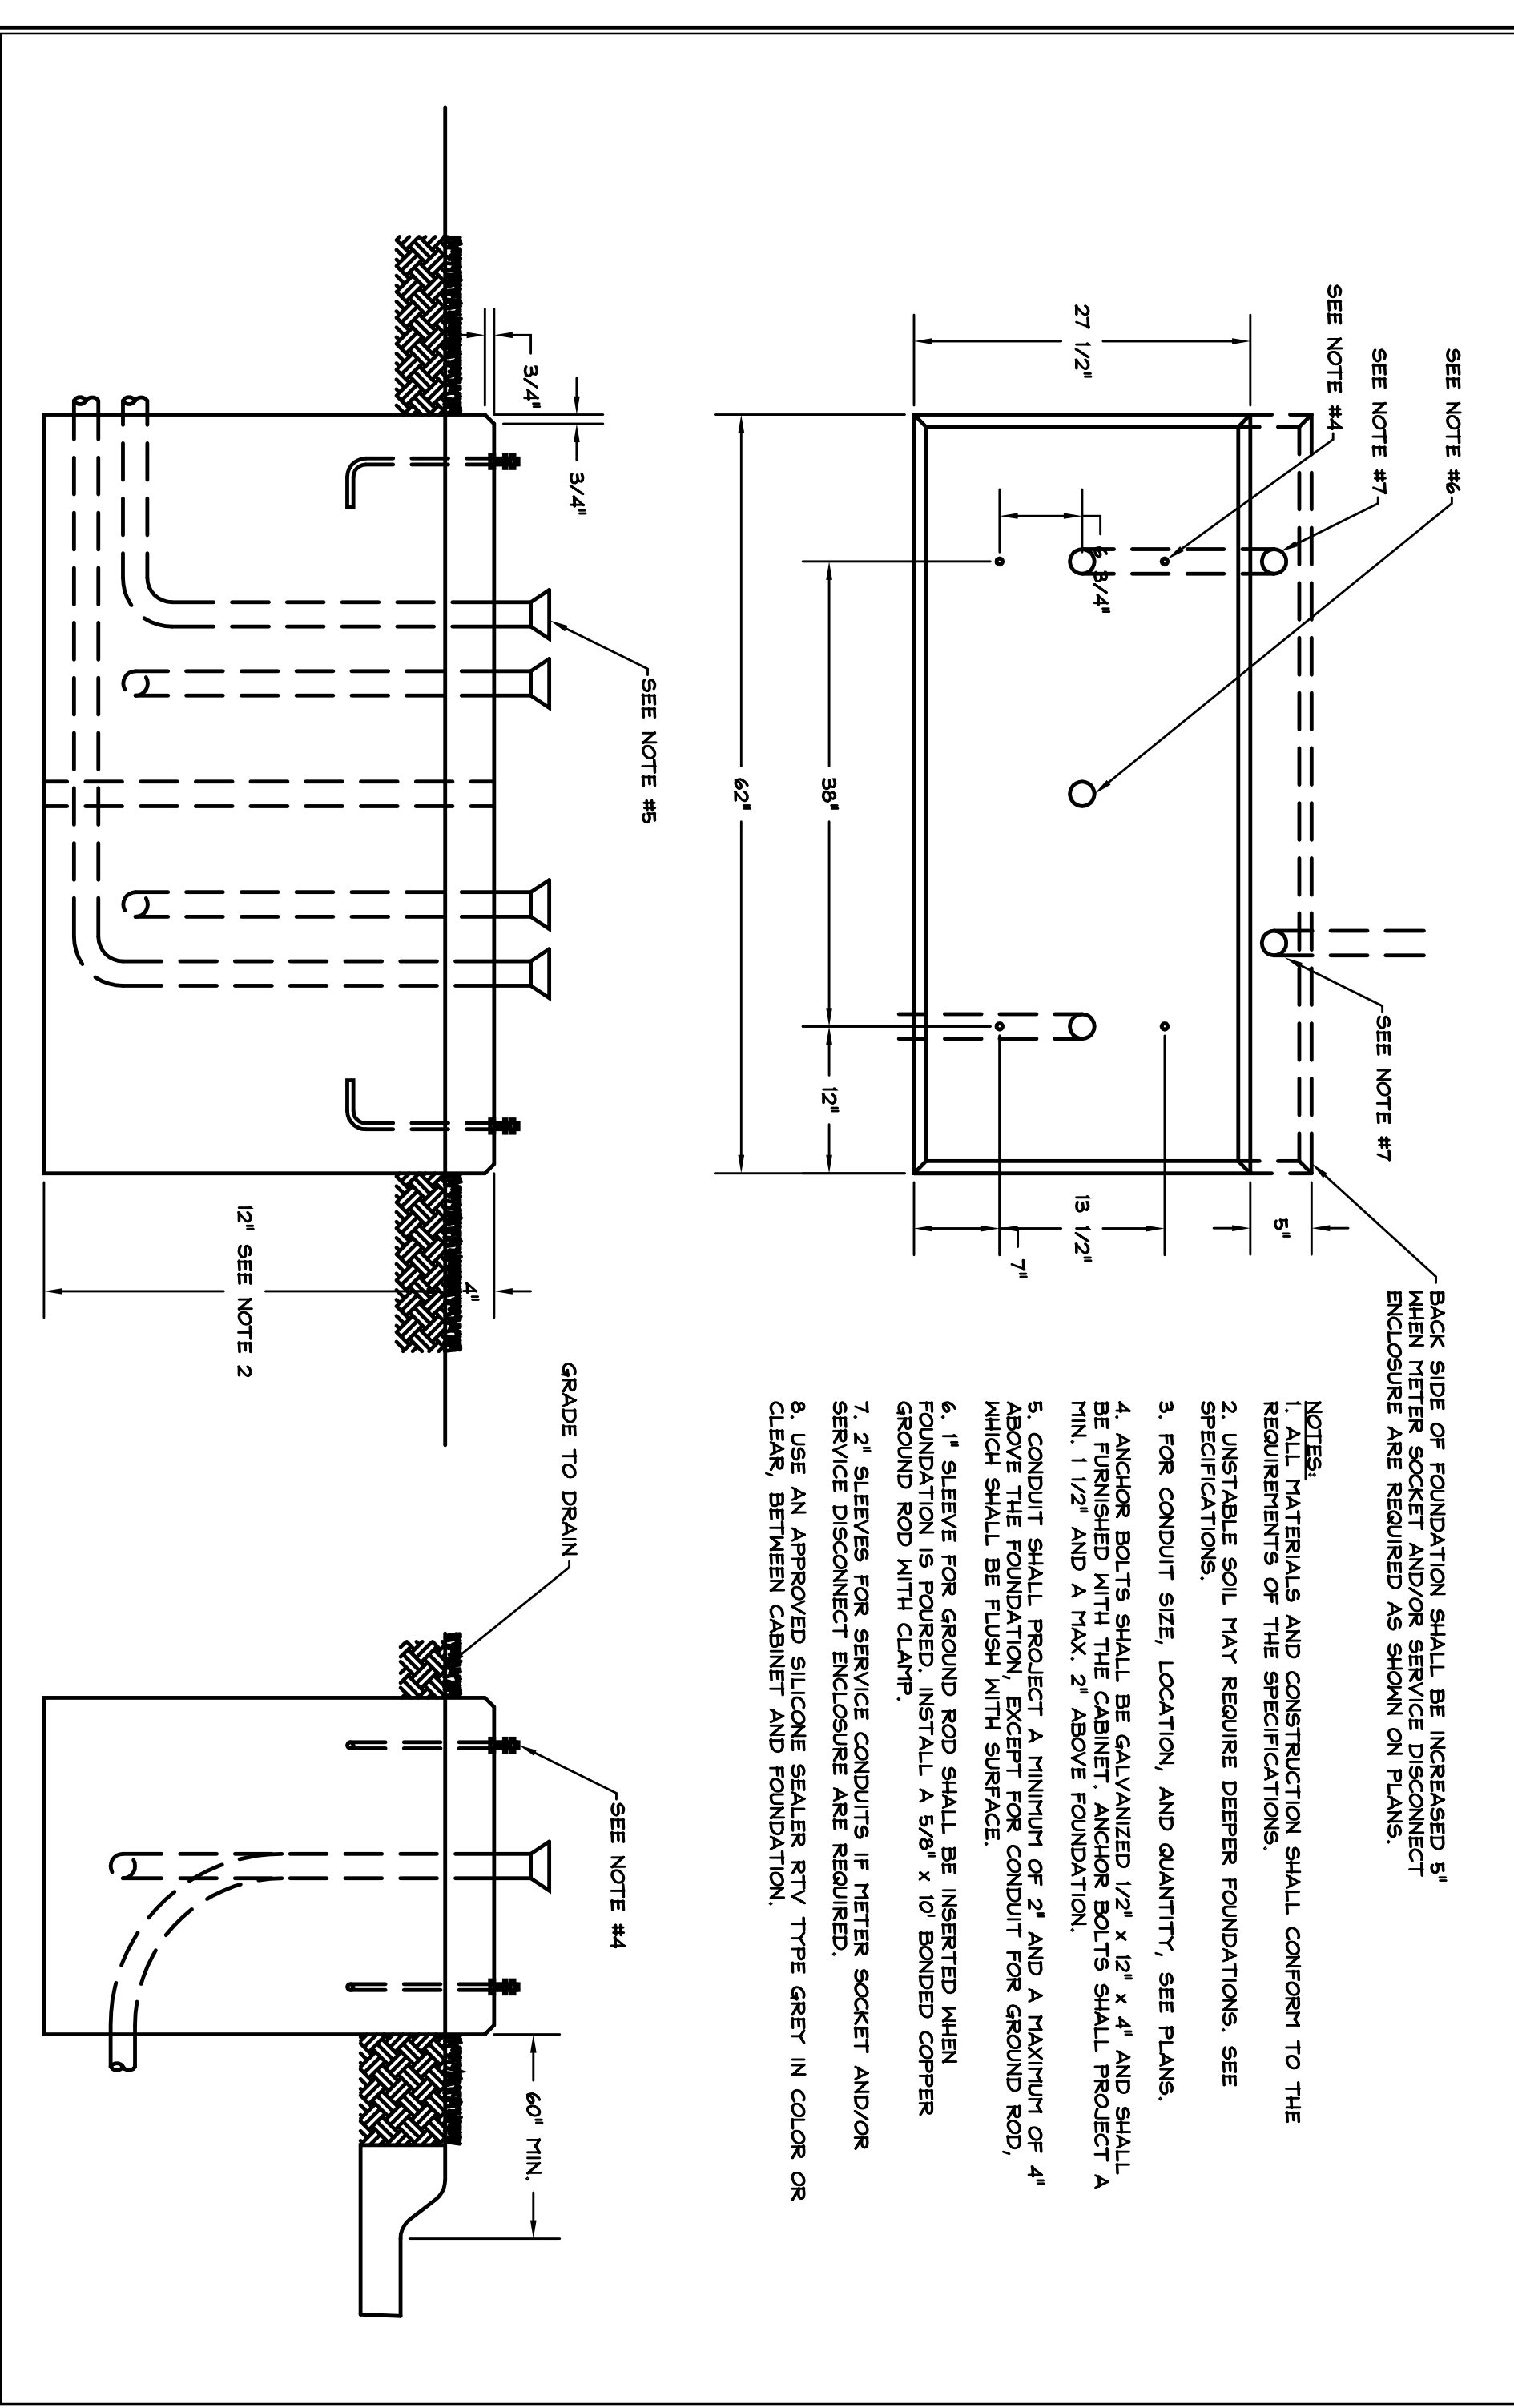

TYPICAL LOAD CENTER CABINET DETAIL

